


DRAINAGE KEY NOTING:		
SYMBOL	DESCRIPTION	SHEET REFERENCE
⬠	INSTALL GRATE INLET	SEE SHT. D-01, #1,2
⊕	INSTALL STORM DRAIN MANHOLE	SEE SHT. D-01, #3
⬠	INSTALL CURB INLET	SEE SHT. D-01, #5,2


REVISIONS			
SYM.	DESCRIPTION	DATE	BY
Δ	ADDENDUM #2, DRAINAGE REVISIONS	03/06/2026	MFL

- NOTES:**
- ALL GENERAL NOTES, ABBREVIATIONS, SYMBOLS, AND OTHER INFORMATION INDICATED ON SHEET C-01 SHALL APPLY TO THIS PLAN.
 - THE PURPOSE OF THE PLAN IS FOR INFORMATIONAL PURPOSES ONLY. THOUGH THIS PLAN IS FROM AN ACTUAL FIELD SURVEY IT IS NOT AND SHOULD NOT BE CONSIDERED A RECORDABLE DOCUMENT.
 - ALL ELEVATIONS SHOWN ARE IN REFERENCE TO THE BENCHMARK AND MUST BE VERIFIED BY THE GENERAL CONTRACTOR WITH THE SURVEYOR OF RECORD PRIOR TO BEGINNING CONSTRUCTION. BENCHMARK IS AN IIP LOCATED WITHIN THE COURTHOUSE SQUARE, HAVING AN ELEVATION OF 583.21'.
 - LOCATIONS OF EXISTING UTILITY LINES HAVE BEEN TAKEN FROM UTILITY RECORDS SUPPLEMENTED BY FIELD INSPECTIONS AND SHOULD INDICATE IN GENERAL THE TYPE OF UNDERGROUND FACILITIES NOW IN SERVICE. HOWEVER, LOCATIONS SHOWN ARE NOT GUARANTEED AND ANY FURTHER DEVELOPERS OR CONTRACTORS SHOULD NOT ONLY MAKE SUBSURFACE INVESTIGATIONS BUT SHOULD ALSO ALLOW FOR CONTINGENCIES WHICH MIGHT ARISE BY REASON OF ENCOUNTERING UNRECORDED LINES OR LINES BEING IN DIFFERENT LOCATIONS THAN INDICATED ON THIS PLAT. COORDINATE ALL ELECTRICAL LINE RELOCATION WITH DUKE PROGRESS ENERGY.
 - HORIZONTAL COORDINATES BASED ON NC GRID NAD83 AND ELEVATIONS BASED ON NAVD88 DATUM.
 - ALL DISTANCES ARE HORIZONTAL GROUND.
 - AREA BY COORDINATE COMPUTATION.
 - SURVEY INFORMATION FROM THE SURVEYOR OF RECORD, LKC ENGINEERING, PLLC; JEFFREY L. GREEN, PLS, LIC. # L-3972; 140 AQUA SHED CT, ABERDEEN, NC 28315, TEL #: 910-420-1437.

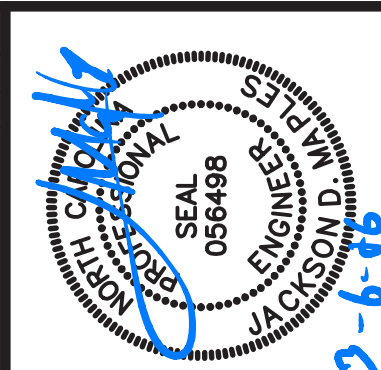

LKC Engineering, PLLC
 140 Aqua Shed Court
 Aberdeen, NC 28315
 O: 910.420.1437
 F: 910.637.0096
 lkceengineering.com
 License No. P-1095

Engineering
 Landscape Architecture
 Surveying

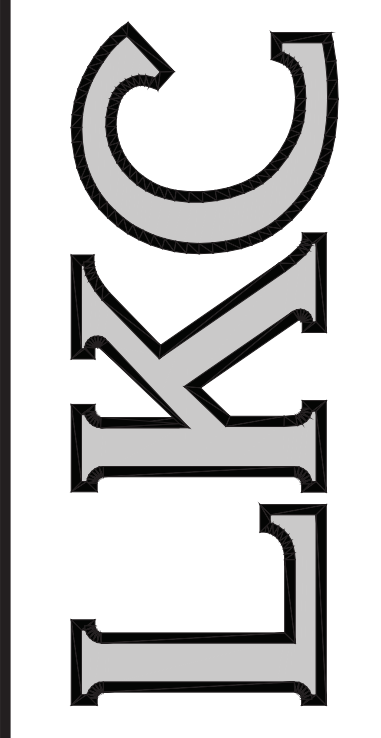


DRAINAGE PLAN

CARTHAGE DOWNTOWN
 REVITALIZATION

Carthage, North Carolina

DATE: MARCH, 2026
 DESIGNED:
 DRAWN: MFL
 CHECKED: JDM

NO. C-5.0

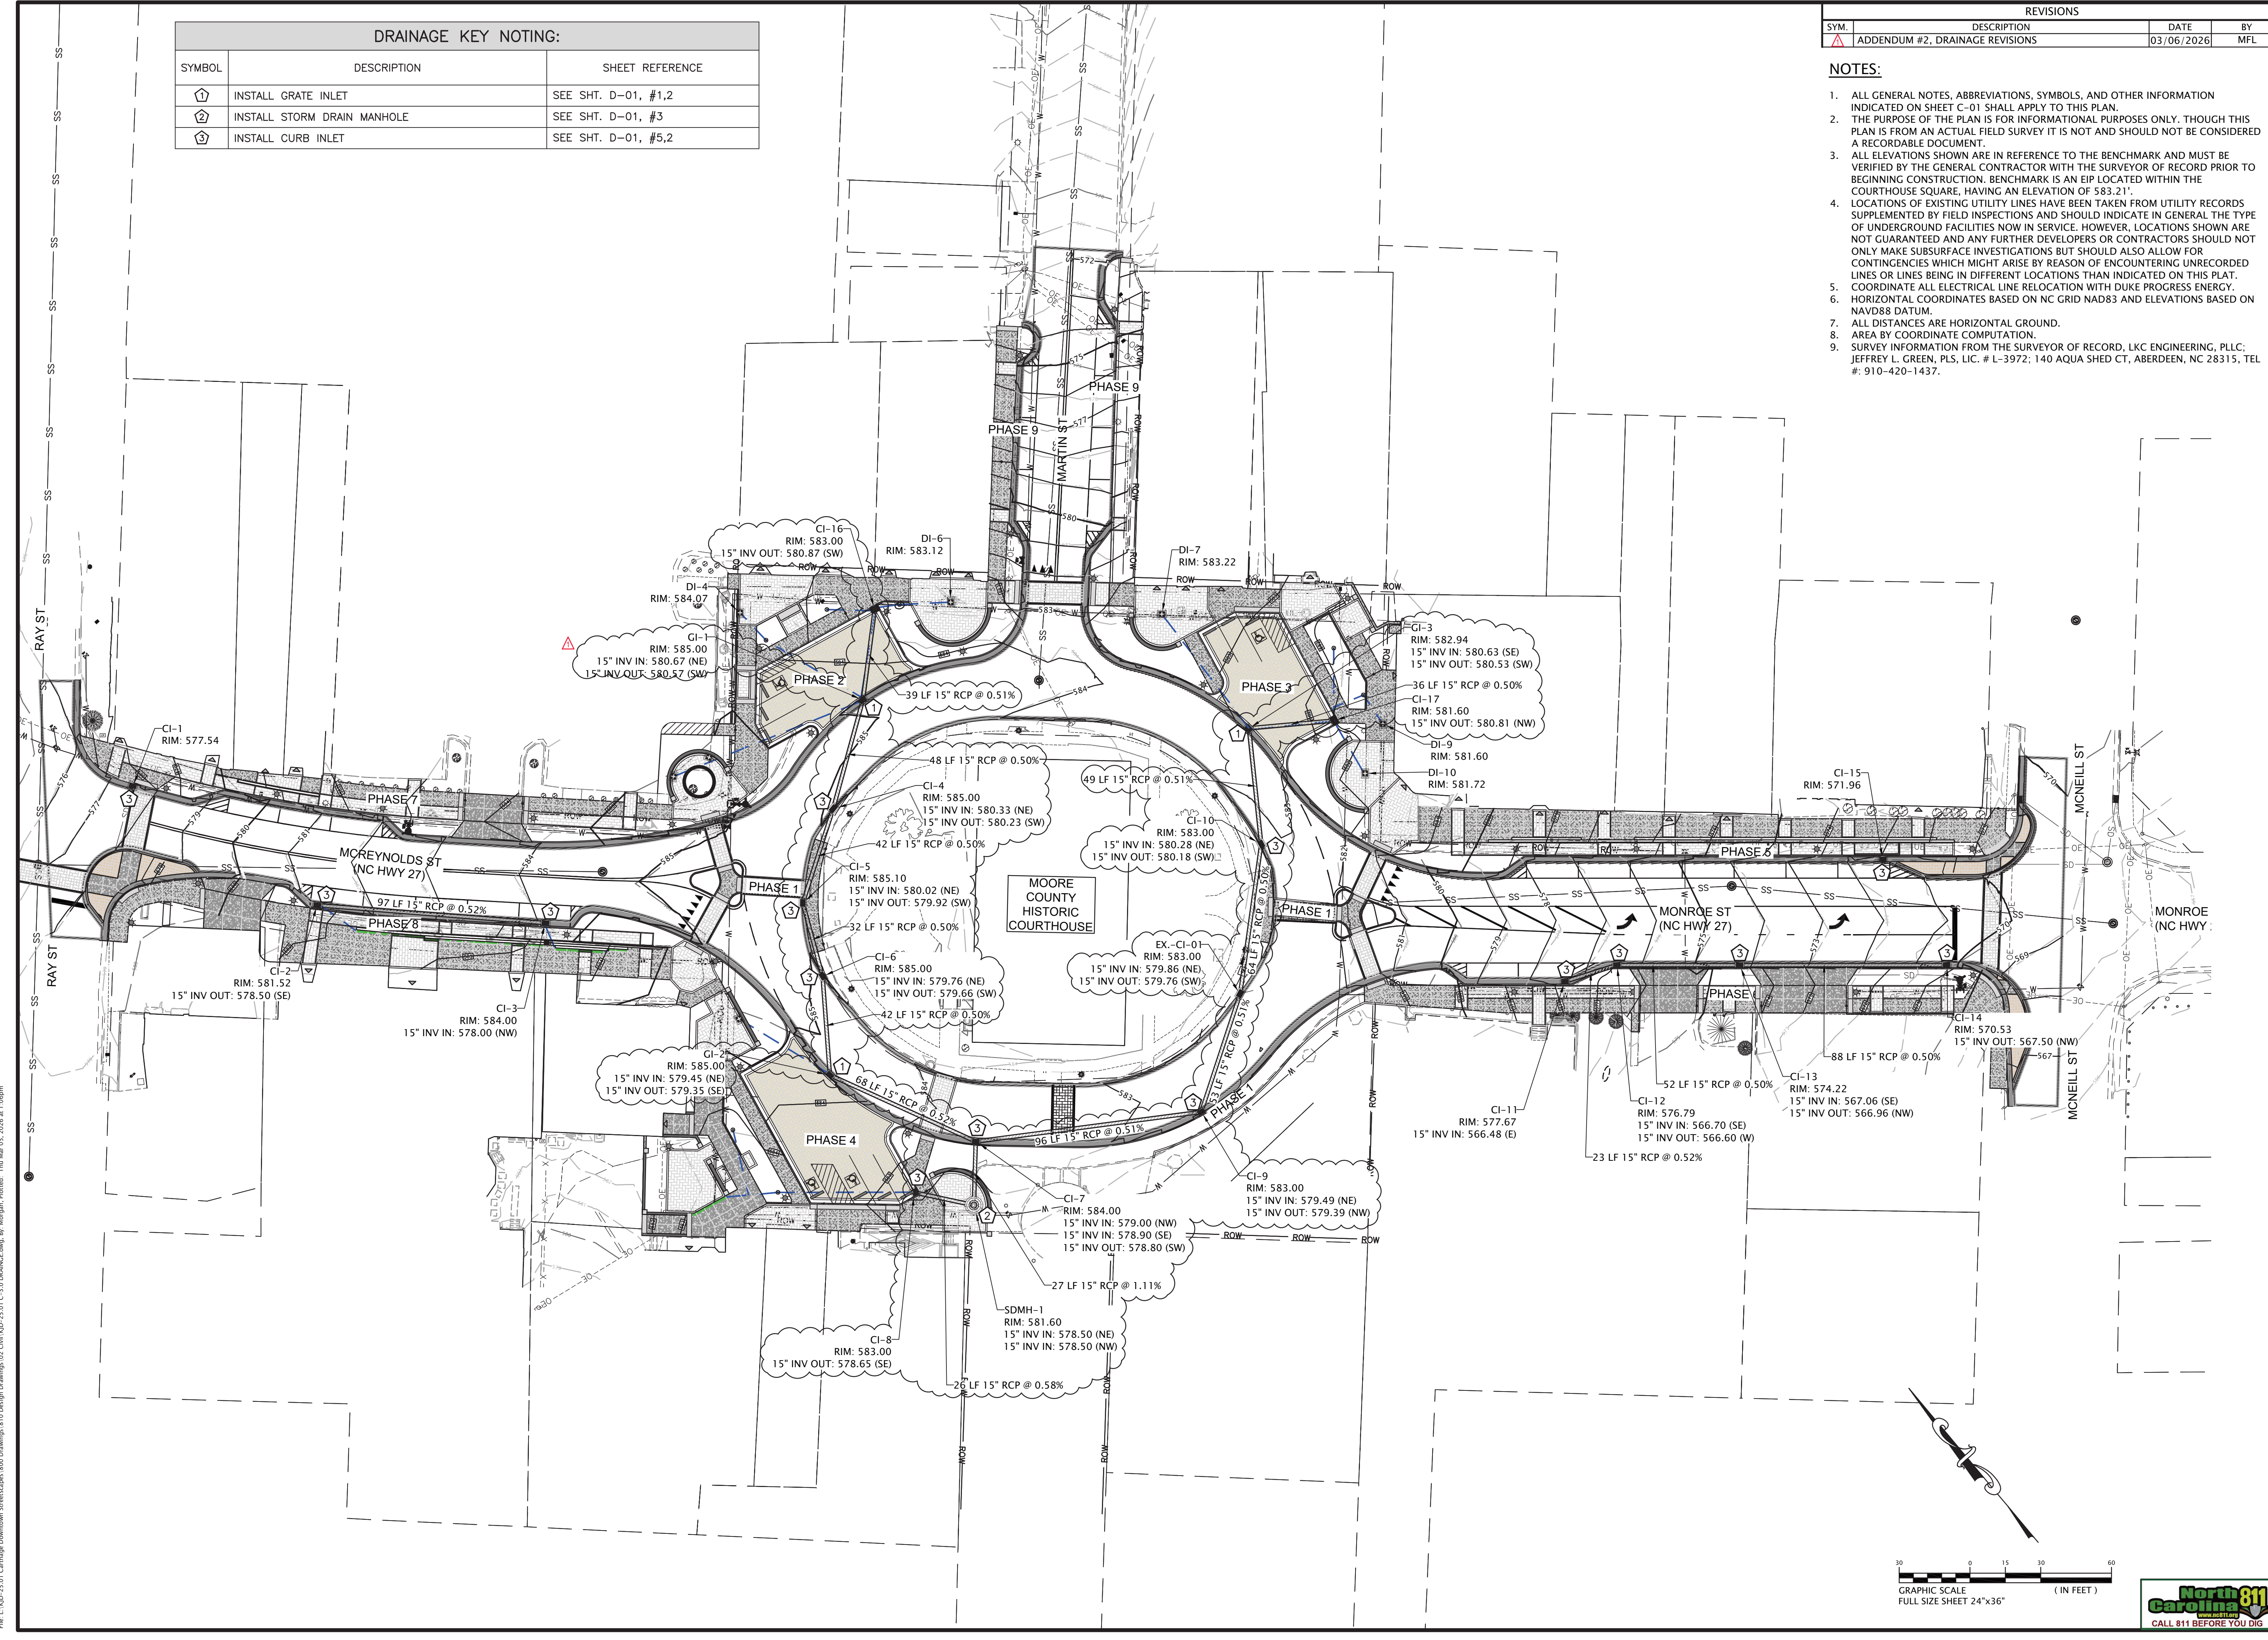

File: L:\100-21.01 Carthage Downtown Streetscape 1800 Drawings\810 Drawings\810 Drawings\810.dwg, By: Morgan, Plotted: Thu Mar 05, 2026 at 1:06pm

